



UNIFILAR TS ESTAR MEDICOS

TABLERO SECCIONAL ESTAR MEDICOS

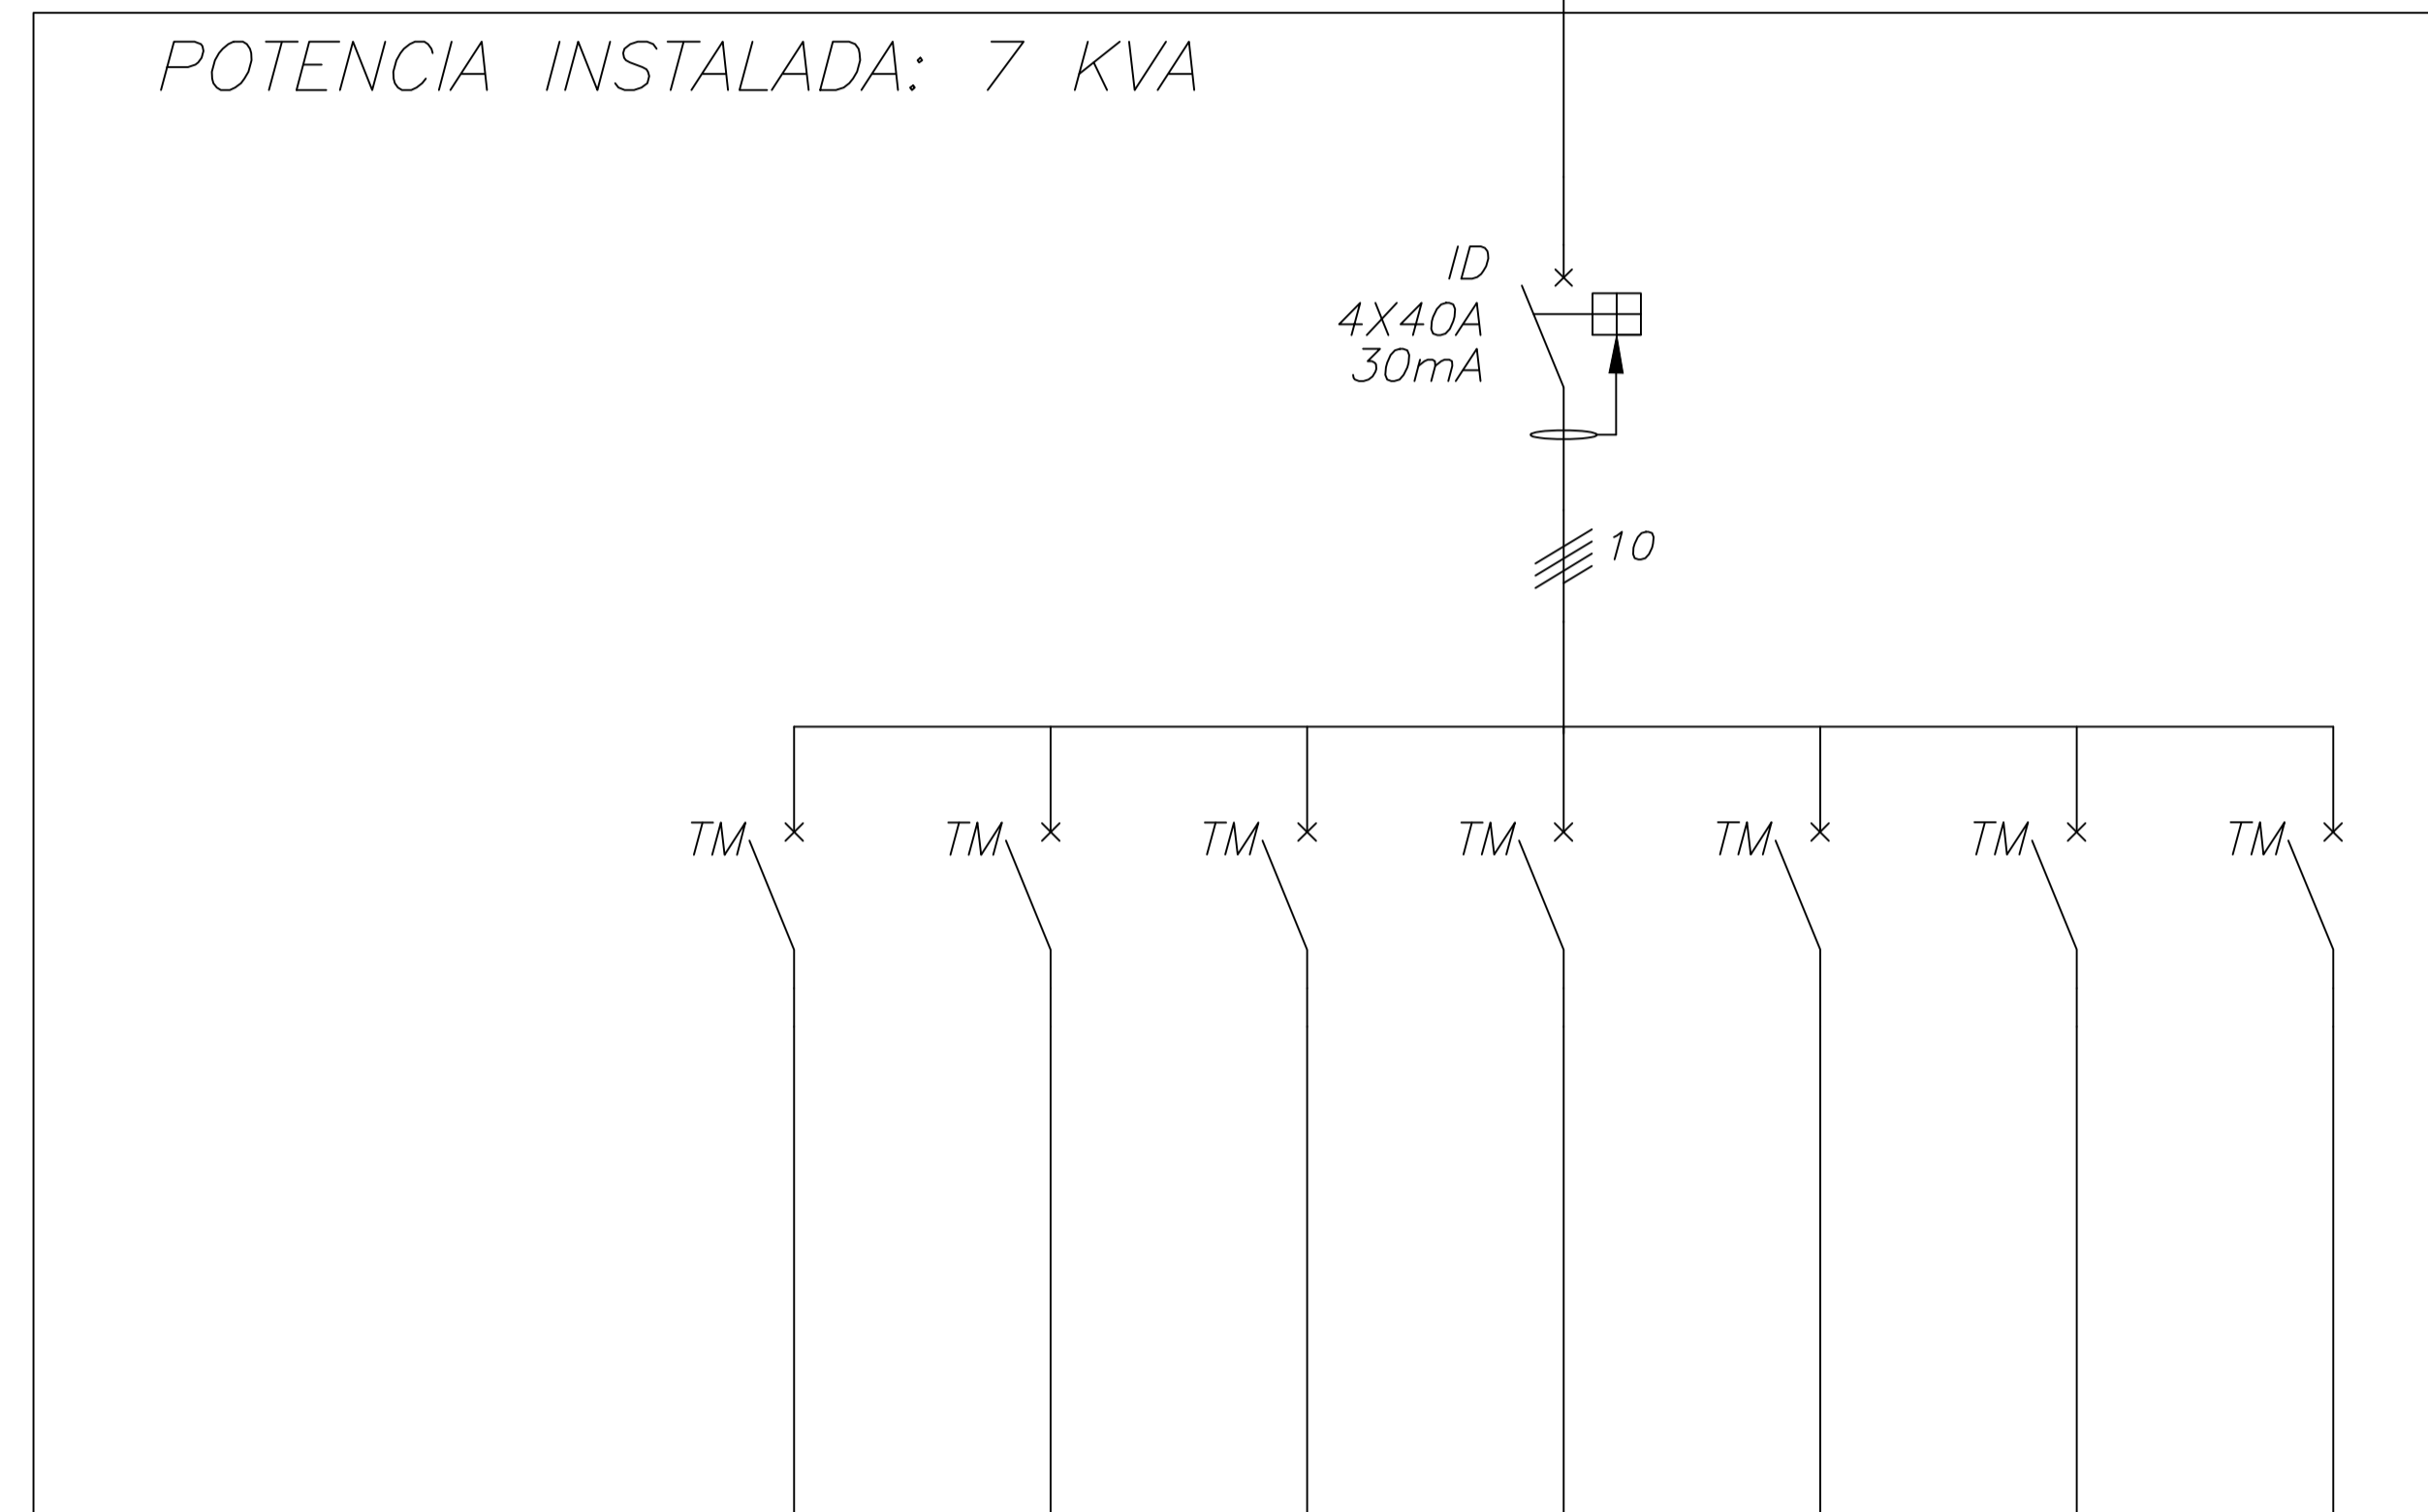

DESTINO	C36	C37	C52	C9	C10	C11	C33
INTERRUPTOR	2X10	2X10	2X10	2X16	2X16	2X16	2X16
SECCION	2X1.5	2X1.5	2X1.5	2X2.5	2X2.5	2X2.5	2X2.5
CABLE TIPO	LS0H	LS0H	LS0H	LS0H	LS0H	LS0H	LS0H
DESTINO	ESTAR MEDICOS	DORMI MED HOMBRES	DORMI EST MED MUJ	ESTAR ENFERMER	DORMI MED H	DORMI MED M	ESTAR MEDICOS

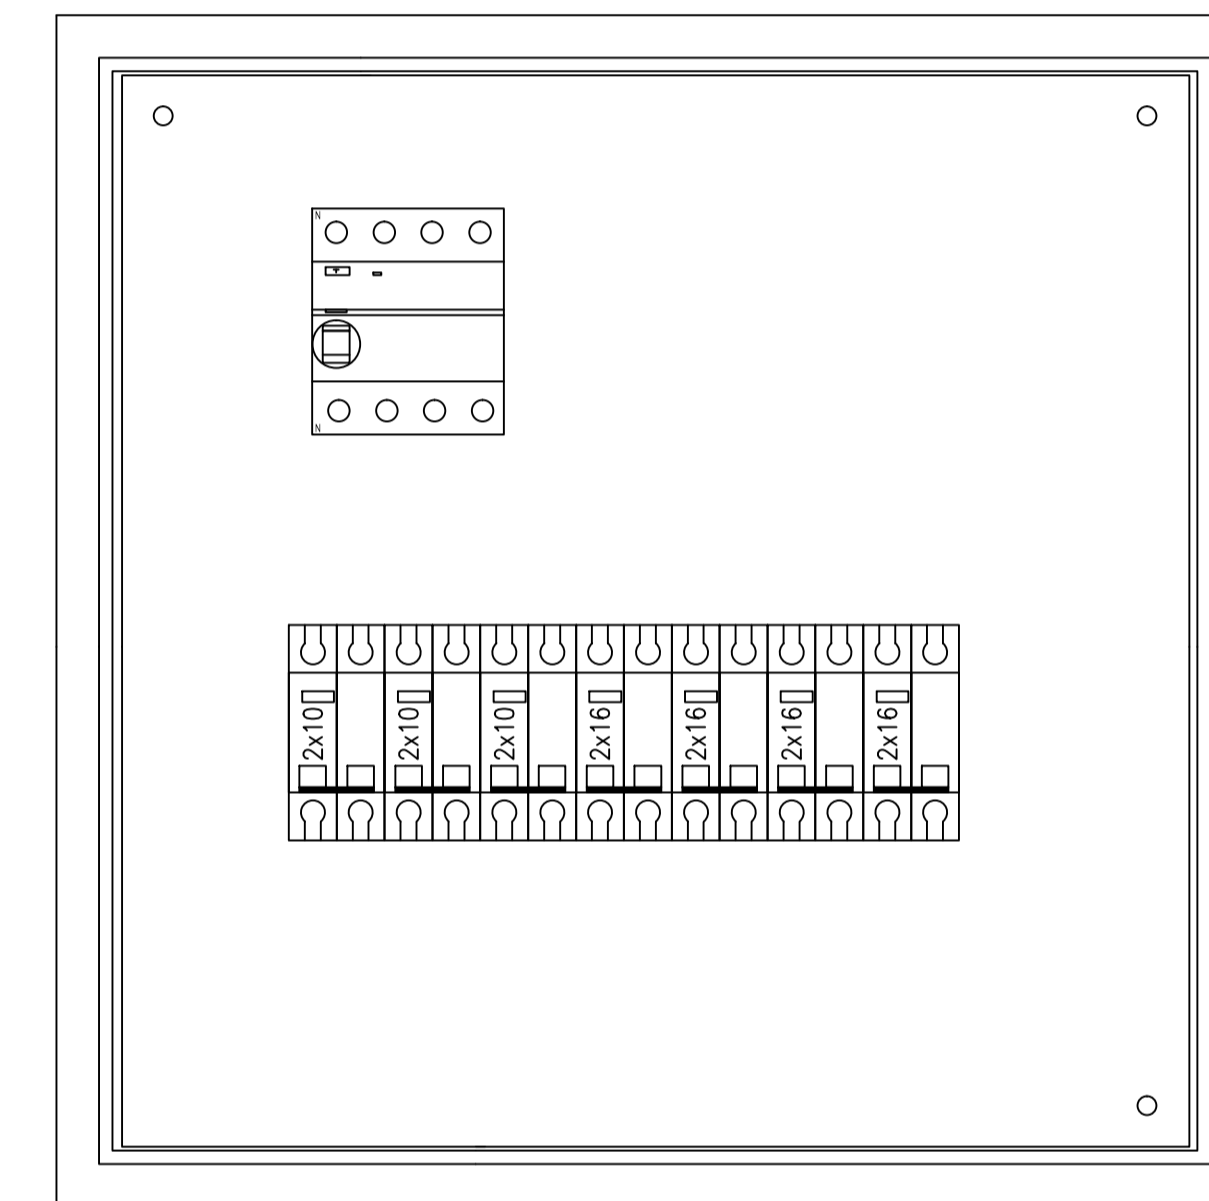

TOPOG. TS ESTAR MEDICOS



HOSPITAL LARCADE
Ampliacion guardias

SECRETARIA DE OBRAS PUBLICAS

ESCALA: 1:100

DIBUJO: TS ESTAR MEDICOS

ARCHIVO: IE-HOSPITAL-TABLEROS-e00.dwg

FECHA: 12/03/21

PLANO:

00